

EXHIBIT C

ENLARGED KIOSK AREA LAYOUT
SCALE: 1" = 5'



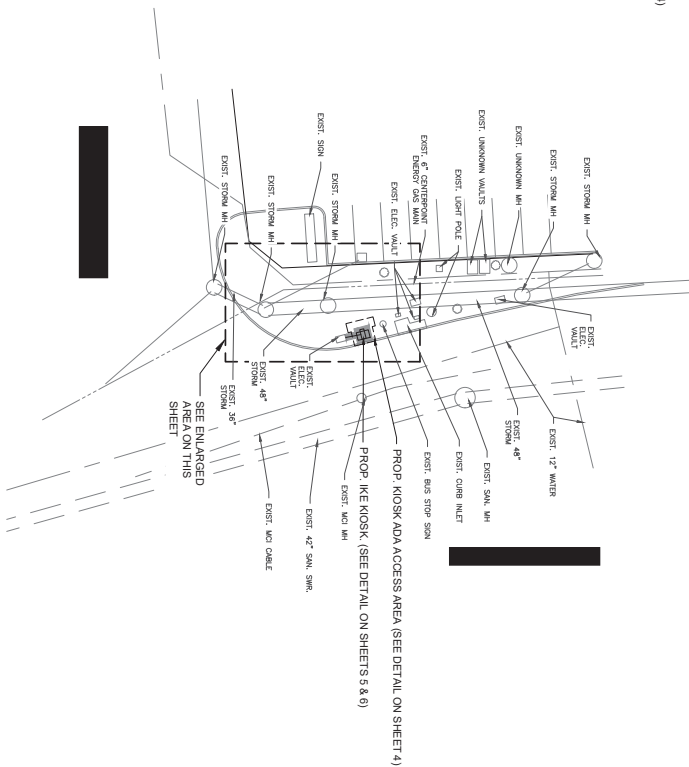


EXHIBIT C

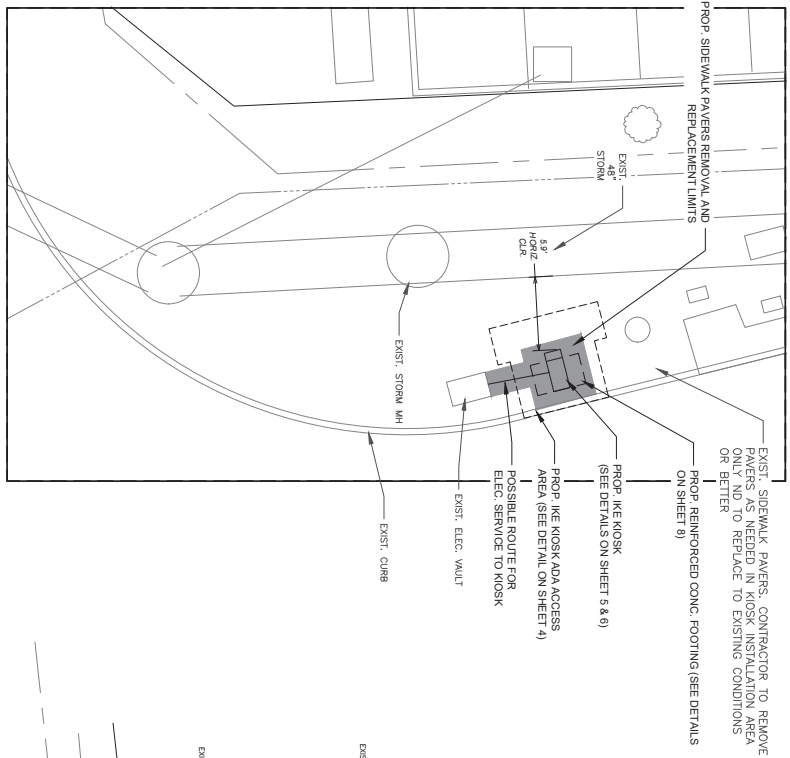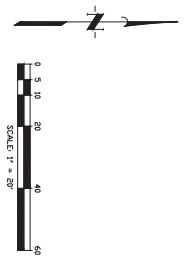

NO.	DATE	REVISION	APP.

NOTICE:
FOR YOUR SAFETY, YOU ARE ADVISED BY [REDACTED] TO CALL 811 AT LEAST 48 HOURS BEFORE ANY EXCAVATION OR OTHER WORK IS PERFORMED TO LOCATE UNDERGROUND UTILITIES. THIS SERVICE IS FREE OF CHARGE TO THE CALLER. THIS SERVICE IS NOT GUARANTEED. CONTACT YOUR LOCAL UTILITY PROVIDER FOR MORE INFORMATION.
Signature valid for six months.

VERIFICATION OF PRIVATE UTILITY LINES
Date: _____
Contractor Energy/Underground Facilities Verification ONLY. (This signature verifies for existing utilities only.)
Signature valid for six months.

Contractor Energy/Underground Facilities Verification ONLY
(This signature verifies for existing utilities only.)
Signature valid for six months.

Required for ALL underground conduct facilities only.
Date: _____
Signature valid for one year.

[REDACTED SIGNATURE]

SITE PLAN

NOTE: CITY SIGNATURES VALID FOR ONE YEAR ONLY AFTER DATE OF SIGNATURES

WATER	STORM WATER QUALITY
WASTE WATER	FACILITIES
STORM WATER	TRAFFIC & MANHOLES/STREET & RIBBON
FILE NO.	HORIZ: 1" = 20'
SHEET NO. 3 OF 8	VERT: 1" = 20'
FOR CITY OF [REDACTED]	DRAWING SCALE